



DOOR TYPES

	TYPE A FULL GLASS (FRAME)		TYPE B FLUSH SWINGING
	TYPE C LOUVERED		TYPE D FLUSH
	TYPE E VISION LITE		TYPE F HALF

DOOR SCHEDULE					
DOOR	LOCATION	SIZE	SWING	TYPE	
17	BANQUET	6'-0" x 7'-0"	CENTER	D	
18	BANQUET	6'-0" x 7'-0"	CENTER	D	
19	BANQUET MEANS BATHROOM	3'-0" x 7'-0"	LEFT	B	
15	BANQUET STORAGE	3'-0" x 7'-0"	RIGHT	D	
10	COMMUNICATION ROOM	3'-0" x 7'-0"	LEFT	C	
8	CONFERENCE ROOM	3'-0" x 7'-0"	RIGHT	D	
3	CONFERENCE ROOM	3'-0" x 7'-0"	RIGHT	D	
14	EMPLOYEE MEN'S BATHROOM	3'-0" x 7'-0"	LEFT	B	
13	EMPLOYEE WOMENS BATHROOM	3'-0" x 7'-0"	RIGHT	A	
5	GYM	3'-0" x 7'-0"	RIGHT	A	
6	GYM WOMENS BATHROOM	3'-0" x 7'-0"	LEFT	B	
21	KITCHEN	6'-0" x 7'-0"	BOTH	F	
22	KITCHEN	3'-0" x 7'-0"	LEFT	F	
23	KITCHEN	3'-0" x 7'-0"	BOTH	F	
25	KITCHEN	6'-0" x 7'-0"	BOTH	F	
26	KITCHEN STORAGE	3'-0" x 7'-0"	LEFT	D	
2	LOBBY MEN'S BATHROOM	3'-0" x 4'-0"	LEFT	B	
3	LOBBY MEN'S BATHROOM	3'-0" x 7'-0"	LEFT	B	
2	LOBBY WOMENS BATHROOM	3'-0" x 7'-0"	RIGHT	B	
12	MECHANICAL ROOM	3'-0" x 7'-0"	RIGHT	C	
7	MEN'S GYM BATHROOM	3'-0" x 7'-0"	RIGHT	B	
23	OFFICE	3'-0" x 7'-0"	RIGHT	D	
24	OFFICE	3'-0" x 7'-0"	RIGHT	D	
25	OFFICE	3'-0" x 7'-0"	RIGHT	D	
360	WOMENS BANQUET BATHROOM	3'-0" x 7'-0"	RIGHT	B	


[illegible]

WINDOW SCHEDULE			
LOCATION	NOTES	SIZE	WINDOW
GYM	CURTAIN WALL	21'-0"x7'-0"	A
BAR/DINING	WATERFALL FFATIRF	20'-7"x7'-0"	B

ELECTRICAL LEGEND	
	TELEPHONE JACK
	TELEVISION CABLE
	110V OUTLET
	110V OUTLET

USE & OCCUPANCY		
ROOM NAME	USE	OCCUPANCY
DINING HALL	A-2	121
BAR	A-2	101
BUSINESS CENTER	B	6
BREAK ROOM	B	2
GYM	GYM W/ EQUIPMENT	16
OFFICE 1	B	1
OFFICE 2	B	1
OFFICE 3	B	1
Cafe	A-2	73
BANQUET HALL A	A-2	89
BANQUET HALL B	A-2	91
BANQUET BRAC	A-2	3
CONFERENCE ROOM 1	B	3
CONFERENCE ROOM 2	B	3
KITCHEN	COMMERCIAL KITCHEN	5
KITCHEN STORAGE	S-2	2
LOBBY	K	59
	TOTAL	598

SHEET INDEX	
SHEET NUMBER	SHEET TITLE
A-1	COVER
A-2	FLOOR PLAN
A-3	FURNITURE PLAN
A-4	REFLECTED CEILING PLAN
A-5	ELEVATIONS/MI WORK

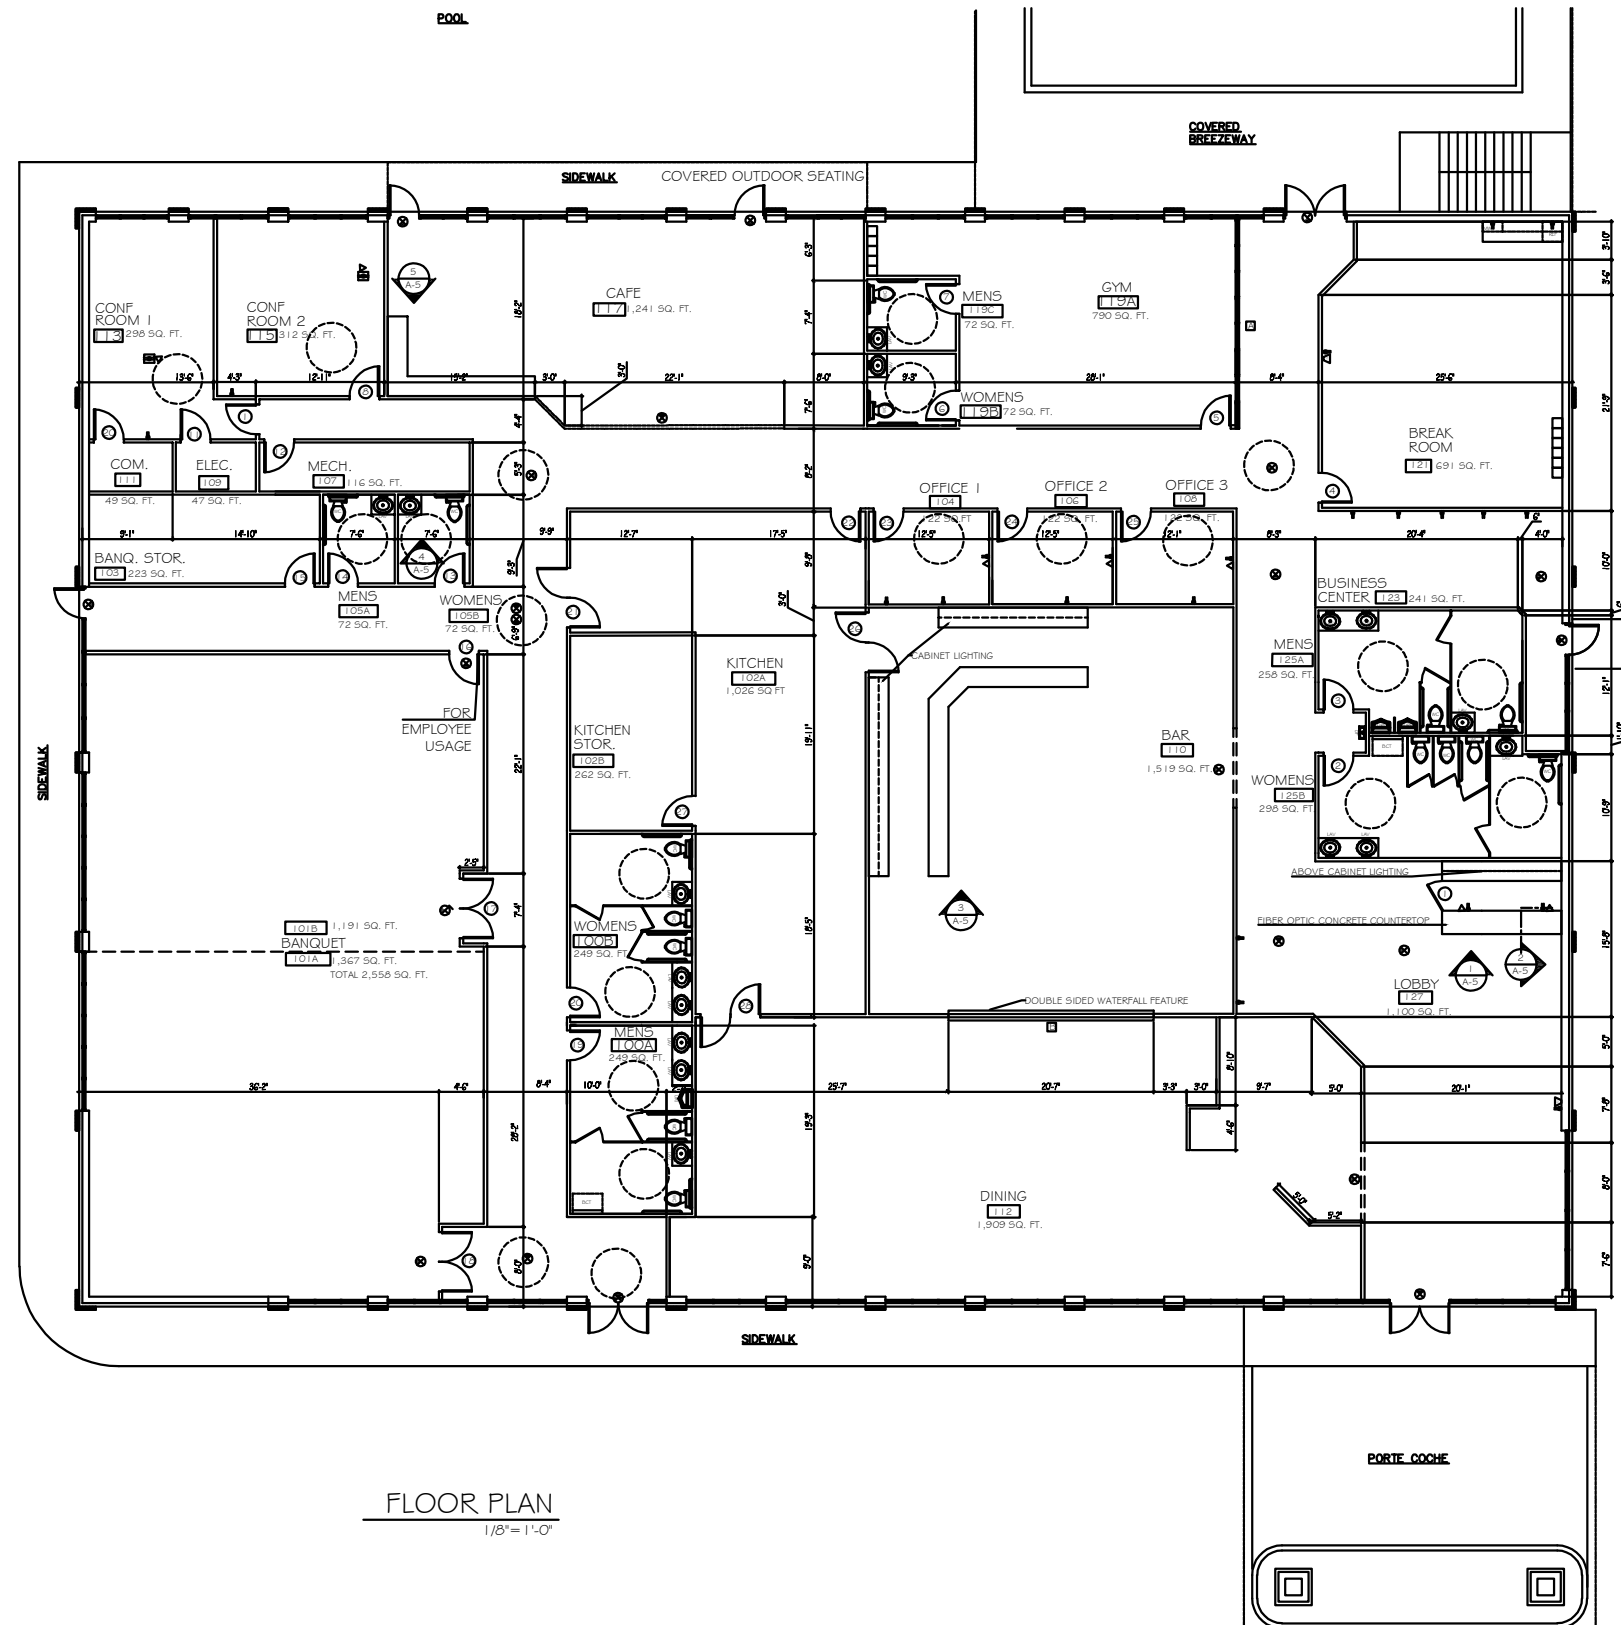

FLOOR PLAN
1/8" = 1'-0"



NAME: SBILLINGSLEY
PAGE TITLE: FLOOR PLAN


SCALE: $\frac{1}{8}"=1'-0"$
DATE: 4/28/18

HOTEL
HERITAGE

A-1

4


FURNITURE SCHEDULE					
MARK	ITEM	MANUFACTURER	DESCRIPTION	FABRIC/ FINISH	REMARKS
A1	CHAIR	SNEVCO	UPHOLSTERED DINING CHAIR, 21"W X 17"D	DARK CHERRY WITH JASMINE BRAND PALLADIO STYLE UPHOLSTERY	GOLD ACCENTS
A2	CHAIR	SNEVCO	TAVERN CHAIR, 21"W X 17"D	OAK	
A3	BARSTOOL	SNEVCO	14"H	OAK	
A4	CHAIR	SNEVCO	OFFICE CHAIR, 21"W X 17"D	BLACK WOVEN STYLE SWITT BRAND FABRIC	3 WAY ADJUSTABLE
A5	CHAIR	SNEVCO	UPHOLSTERED CHAIR, 21"W X 17"D	DARK CHERRY WITH VELEZ BRAND GRAND ROYALE STYLE FABRIC	BUTTONS IN UPHOLSTERY
A6	COUCH	SNEVCO	2 PERSON COUCH	DARK CHERRY FRAME WITH VELEZ BRAND GRAND ROYALE STYLE FABRIC	WITH 2 PILLOWS
A7	COUCH	SNEVCO	3 PERSON COUCH	DARK CHERRY FRAME WITH VELEZ BRAND GRAND ROYALE STYLE FABRIC	WITH 3 PILLOWS
A8	CHAIR	SNEVCO	CAFE CHAIR, 21"W X 17"D	OAK	
A9	BENCH	SNEVCO	2 PERSON BENCH	OAK	
A10	BENCH	SNEVCO	PIANO BENCH	DARK CHERRY	
B1	TABLE	BILLINGSLEY	10 PERSON TABLE 10'-6" X 2'	DARK CHERRY	FLAME GRAIN TOP
B2	TABLE	BILLINGSLEY	6 PERSON TABLE 6'-2" X 2'-6"	DARK CHERRY	QUILTED GRAIN TOP
B3	TABLE	BILLINGSLEY	2 PERSON TABLE 2' X 2'	DARK CHERRY	QUILTED GRAIN TOP
B4	TABLE	BILLINGSLEY	4 PERSON TABLE 2'-6" X 4'-4"	DARK CHERRY	QUILTED GRAIN TOP
B5	TABLE	BILLINGSLEY	4 PERSON TABLE 3'H	OAK	GOLD INLAY 3" FROM TABLE TOP EDGE
B6	TABLE	BILLINGSLEY	2 PERSON TABLE 2'H	OAK	GOLD INLAY 3" FROM TABLE TOP EDGE
B7	TABLE	BILLINGSLEY	8 PERSON TABLE 5'H	OAK	GOLD INLAY 3" FROM TABLE TOP EDGE
B8	TABLE	BILLINGSLEY	COFFEE TABLE 2'-6" X 5'	DARK CHERRY	MATTE FINISH
B9	TABLE	BILLINGSLEY	SIDE TABLE 1'-9" X 1'-9"	DARK CHERRY	MATTE FINISH
B10	TABLE	BILLINGSLEY	4 PERSON TABLE 3' X 3'	OAK	NATURAL
C1	WET BAR	SHALLIGAN	3'W X 2'-2"D	OAK	
D1	PIANO	MCDANIELD	GRAND PIANO	SMOOTH BLACK FINISH	

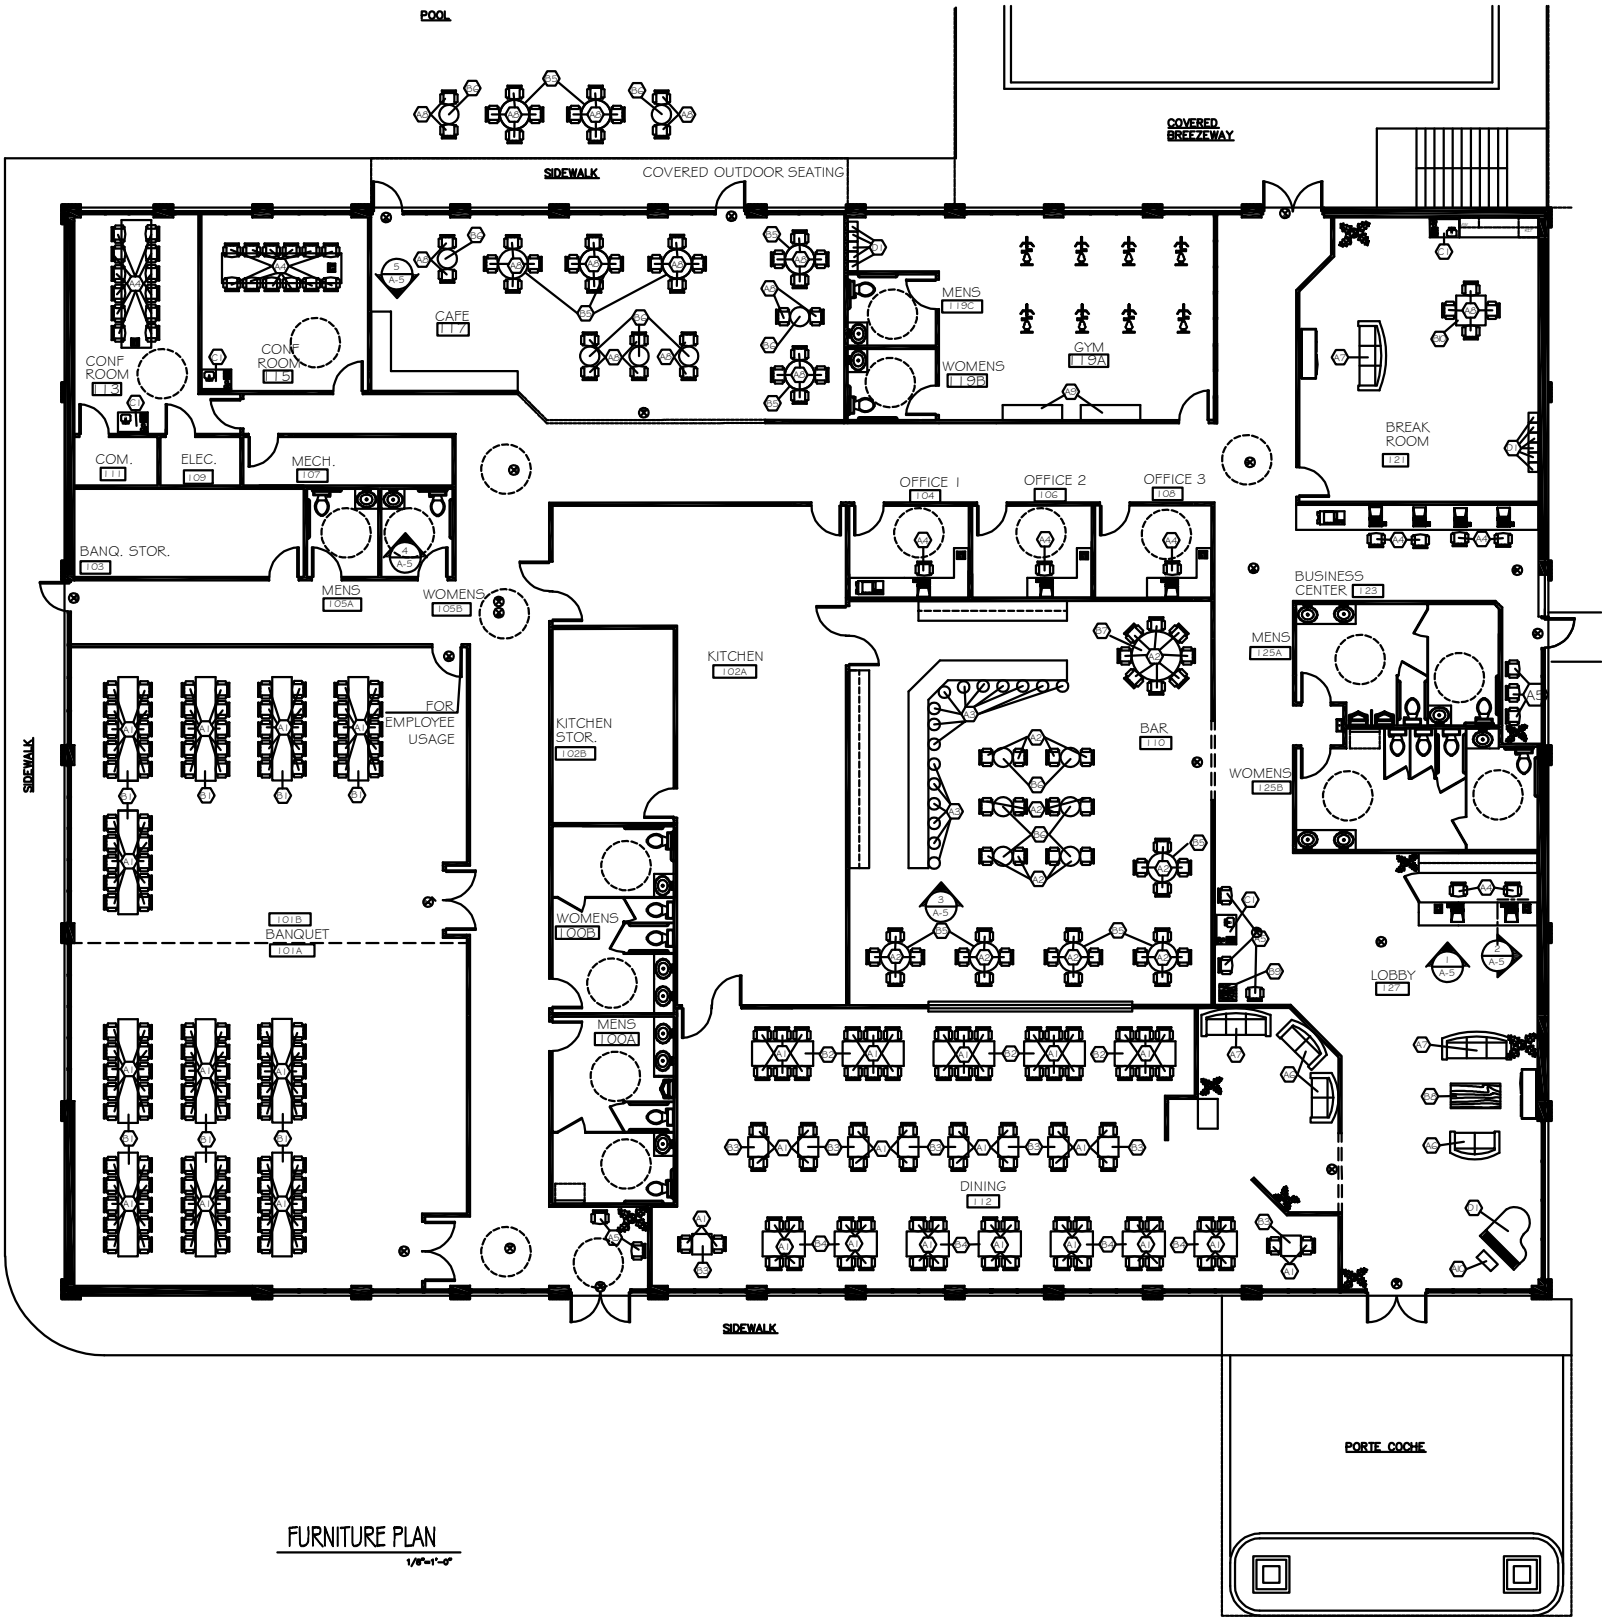

FURNITURE PLAN
1/8"=1'-0"

RCP SYMBOLS LEGEND

	STRIP LIGHTING
	CEILING FAN
	WALL SCONCE
	PENDANT
	6" RECESSED LIGHTING
	CHANDELIER
	PICTURE LIGHT
	SUPPLY VENT
	RETURN VENT
	STRIP SUPPLY VENT
	STRIP RETURN VENT
	SPEAKER
	EXIT LIGHT
	SPRINKLER
	COVE LIGHTING
	EMERGENCY LIGHTS

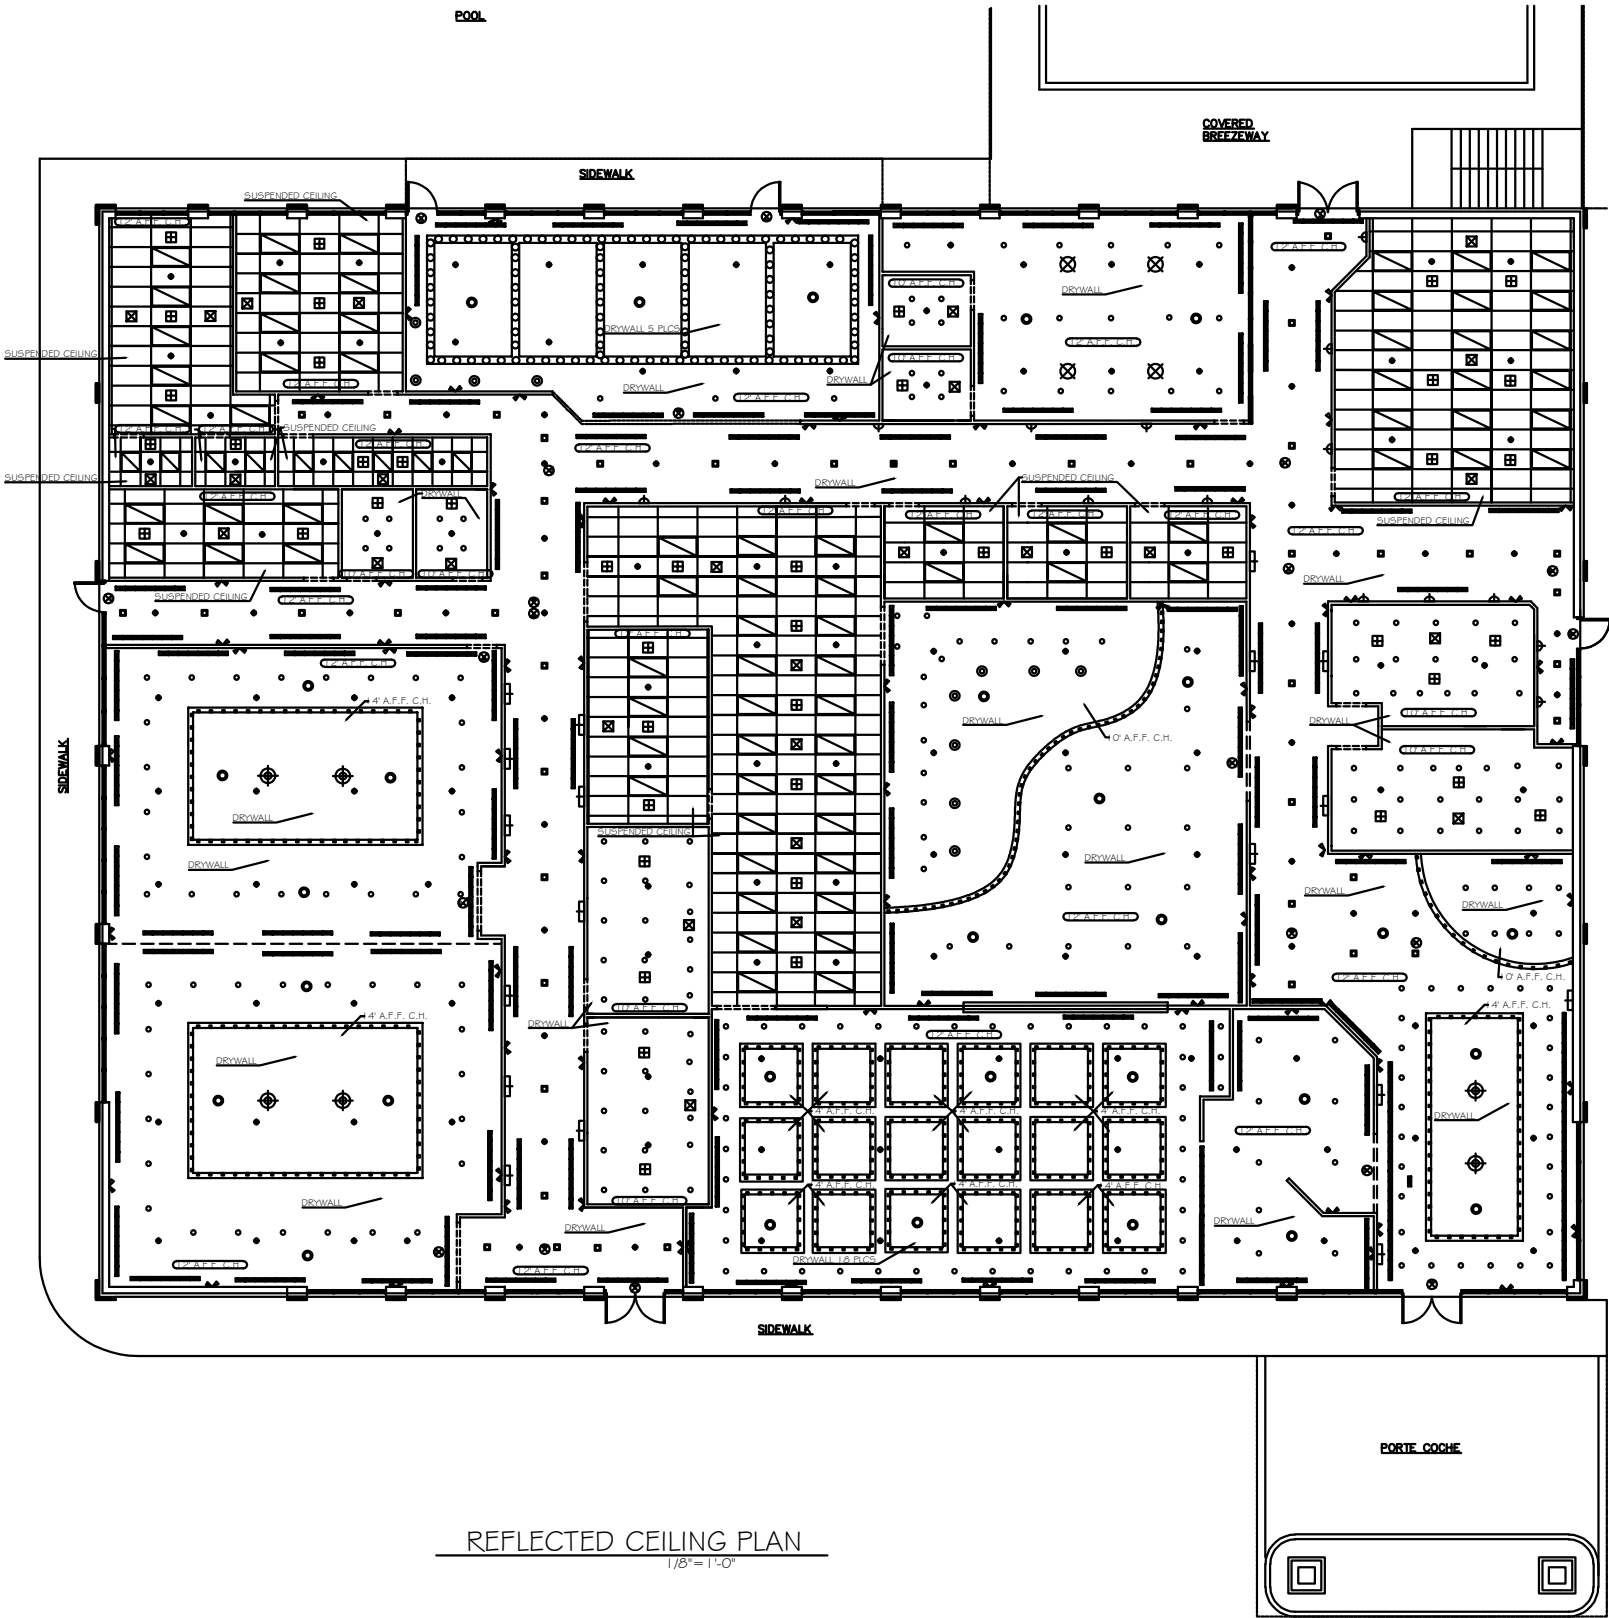

NAME: S BILLINGSLEY

PAGE TITLE: REFLECTED CLG. PLAN

SCALE: 1/8"=1'-0"

DATE:4/28/18

HOTEL
HERITAGE

A-3

4

